


SYMBOL LEGEND	
[Symbol]	INDICATES "PUSH EXIT DEVICES" (PUSH BAR)
[Symbol]	INDICATES FIRE EXTINGUISHER TYPE & A.C. OR D.C. SIZE
[Symbol]	INDICATES INTERNALLY ILLUMINATED EXIT SIGN CONNECTED TO IBC APPROVED EMERGENCY POWER SOURCE
[Symbol]	INDICATES INTERNALLY ILLUMINATED EXIT SIGN WITH INTEGRATED EMERGENCY LIGHTING HEADS, CONNECTED TO IBC APPROVED EMERGENCY POWER SOURCE
[Symbol]	INDICATES EMERGENCY LIGHTING FIXTURE WITH INTEGRATED IBC APPROVED EMERGENCY POWER SOURCE
[Symbol]	INDICATES "REMOTE HEAD" EMERGENCY LIGHTING FIXTURE CONNECTED TO IBC APPROVED EMERGENCY POWER SOURCE
[Symbol]	INDICATES LOCATION OF SMOKE DETECTOR, AS PART OF IBC APPROVED INTERCONNECTED SYSTEM, WHICH SHOWN ON DRAWINGS, EXTENDED FIRE ALARM/SMOKE DETECTOR SYSTEM SHALL BE CONNECTED TO REMOTE CENTRAL MONITOR STATION
[Symbol]	INDICATES LOCATION OF "MANUAL PULL" BOX AS PART OF FIRE ALARM/SMOKE DETECTOR SYSTEM
[Symbol]	INDICATES LOCATION OF "HORN" AND "VISIBLE STROBE" LIGHT FEATURE OF FIRE ALARM/SMOKE DETECTOR SYSTEM

TENANT "B" - REFLECTED CEILING PLAN - ELECTRICAL

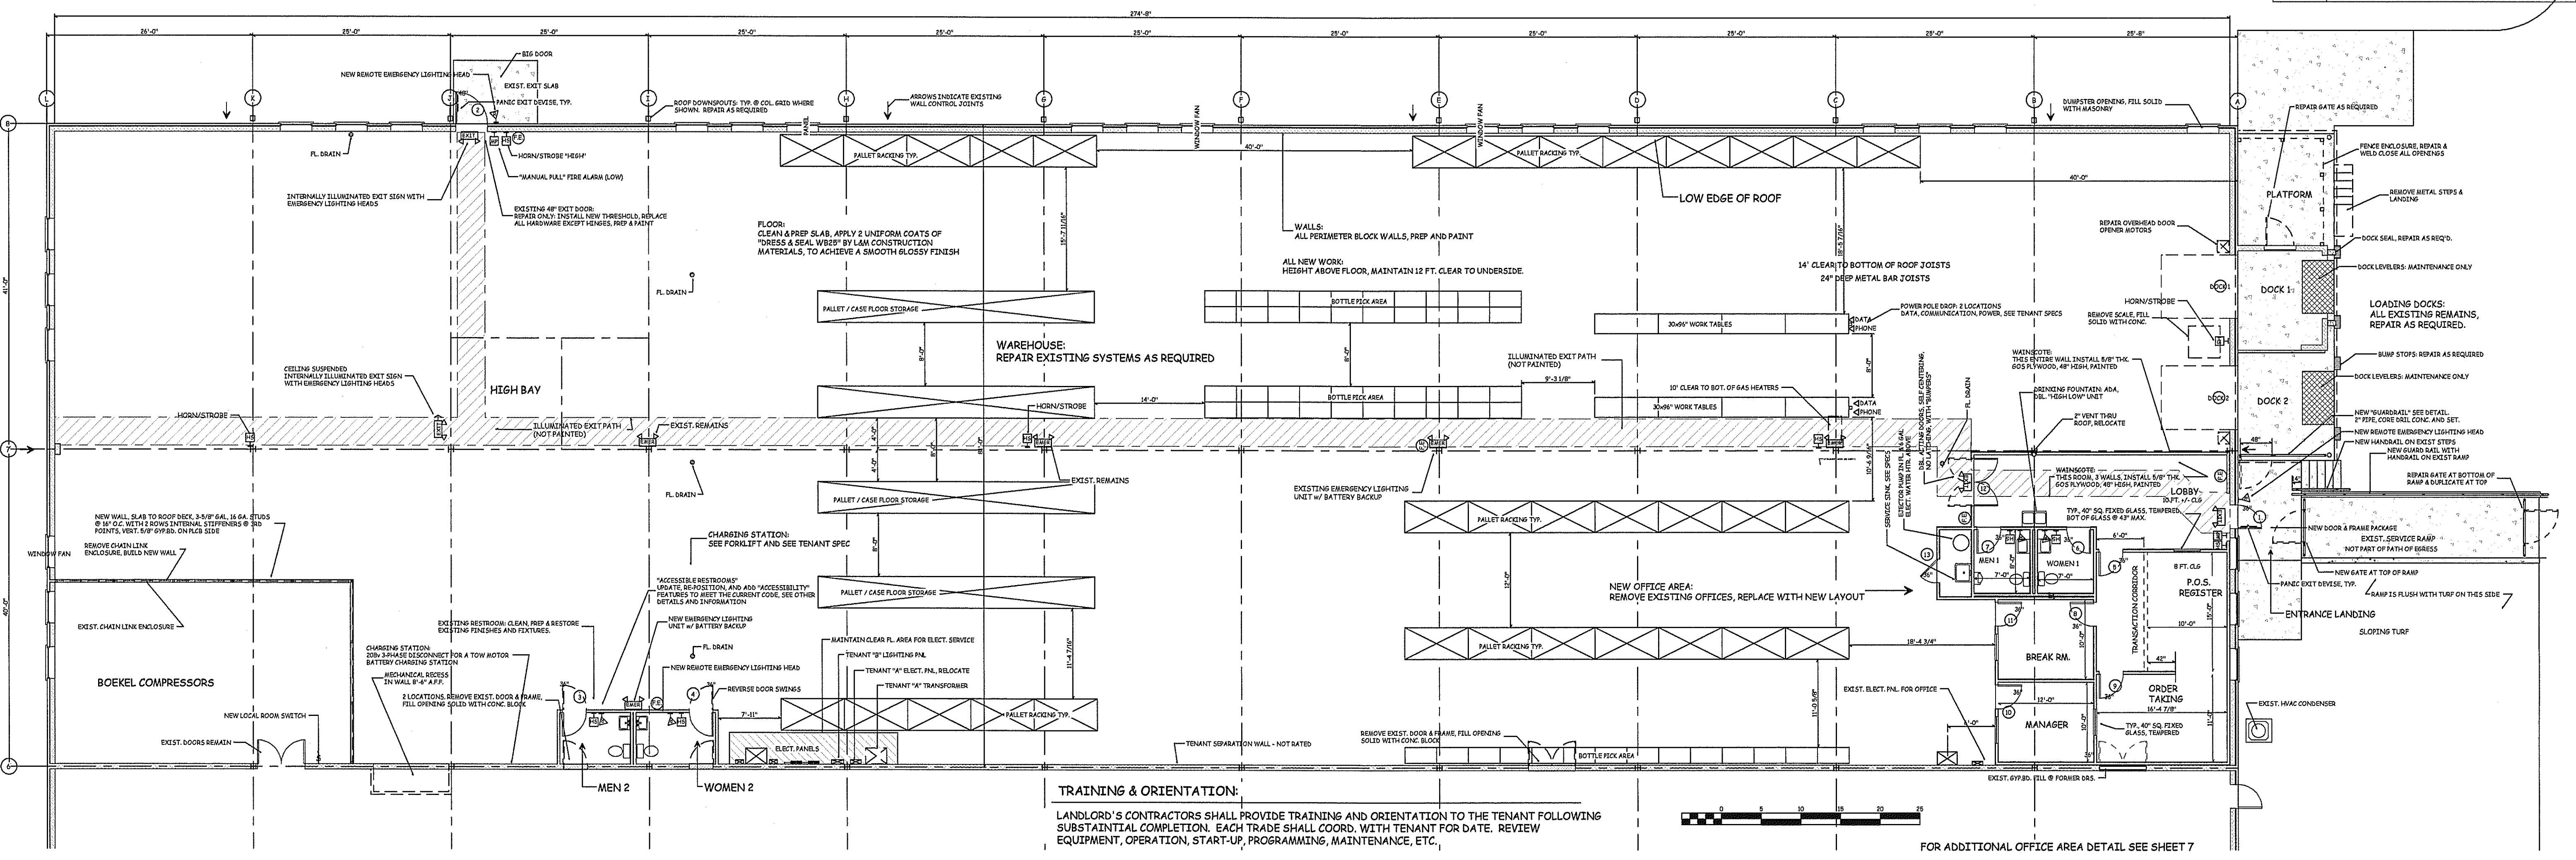

TENANT "B" - FLOOR PLAN & LIFE SAFETY

REV. #	DATE	REVISION DESCRIPTION
03-21-2013	03-21-2013	START UP
05-02-2013	05-02-2013	PROGRESS REVIEW
06-03-2013	06-03-2013	FOR PERMIT REVIEW
06-13-2013	06-13-2013	PERMIT UPDATES

PLANS NOT VALID FOR PERMITS UNLESS SIGNED IN "RED" & IMPRESSED w/ SEAL

Eric C. Van Reed, Architect  
**Creative Design Associates, Inc.**  
 INTERIORS SITE & SPACE PLANNING  
 ARCHITECTURE INTERIORS  
 File: PA080811X  
 350 Callowhill Road  
 Chalfont, PA 18914-1521  
 NJ: 21400808100  
 215-672-1155  
 www.ArchitectVision.com

**E. R. B. & SONS, Inc.**  
 General Contracting & Building  
 Lic. # PA0803365  
 1117 Eagle Road  
 Huntingdon Valley, PA 19008  
 Voice: 267-226-7451

855 Pennsylvania Blvd.  
 "UNIT B" TENANT FIT-OUT  
 Township of Lower Southampton, Bucks County, PA

Sheet No.  
**3**  
 Comm. No. 2013-2967 of 9